


2 STORM RISER DIAGRAM - PLUMBING
P-103

SOME UNITS ARE OPPOSITE HAND

P-103 DRAWING NOTES

1. INSTALLATION OF 4" STORM CONDUCTOR AND ROOF DRAIN DEPICTED IN THIS SCHEMATIC IS BASED UPON A DUPLEX TOWNHOUSE CONSTRUCTION. SINGLE TOWNHOUSES SHALL OMIT THIS PIPING ENTIRELY.
2. INSTALLATION OF 4" STORM CONDUCTOR AND ROOF DRAIN DEPICTED IN THIS SCHEMATIC IS BASED UPON A DUPLEX TOWNHOUSE CONSTRUCTION. SINGLE TOWNHOUSES SHALL CARRY 3" STORM CONDUIT/PIPING.

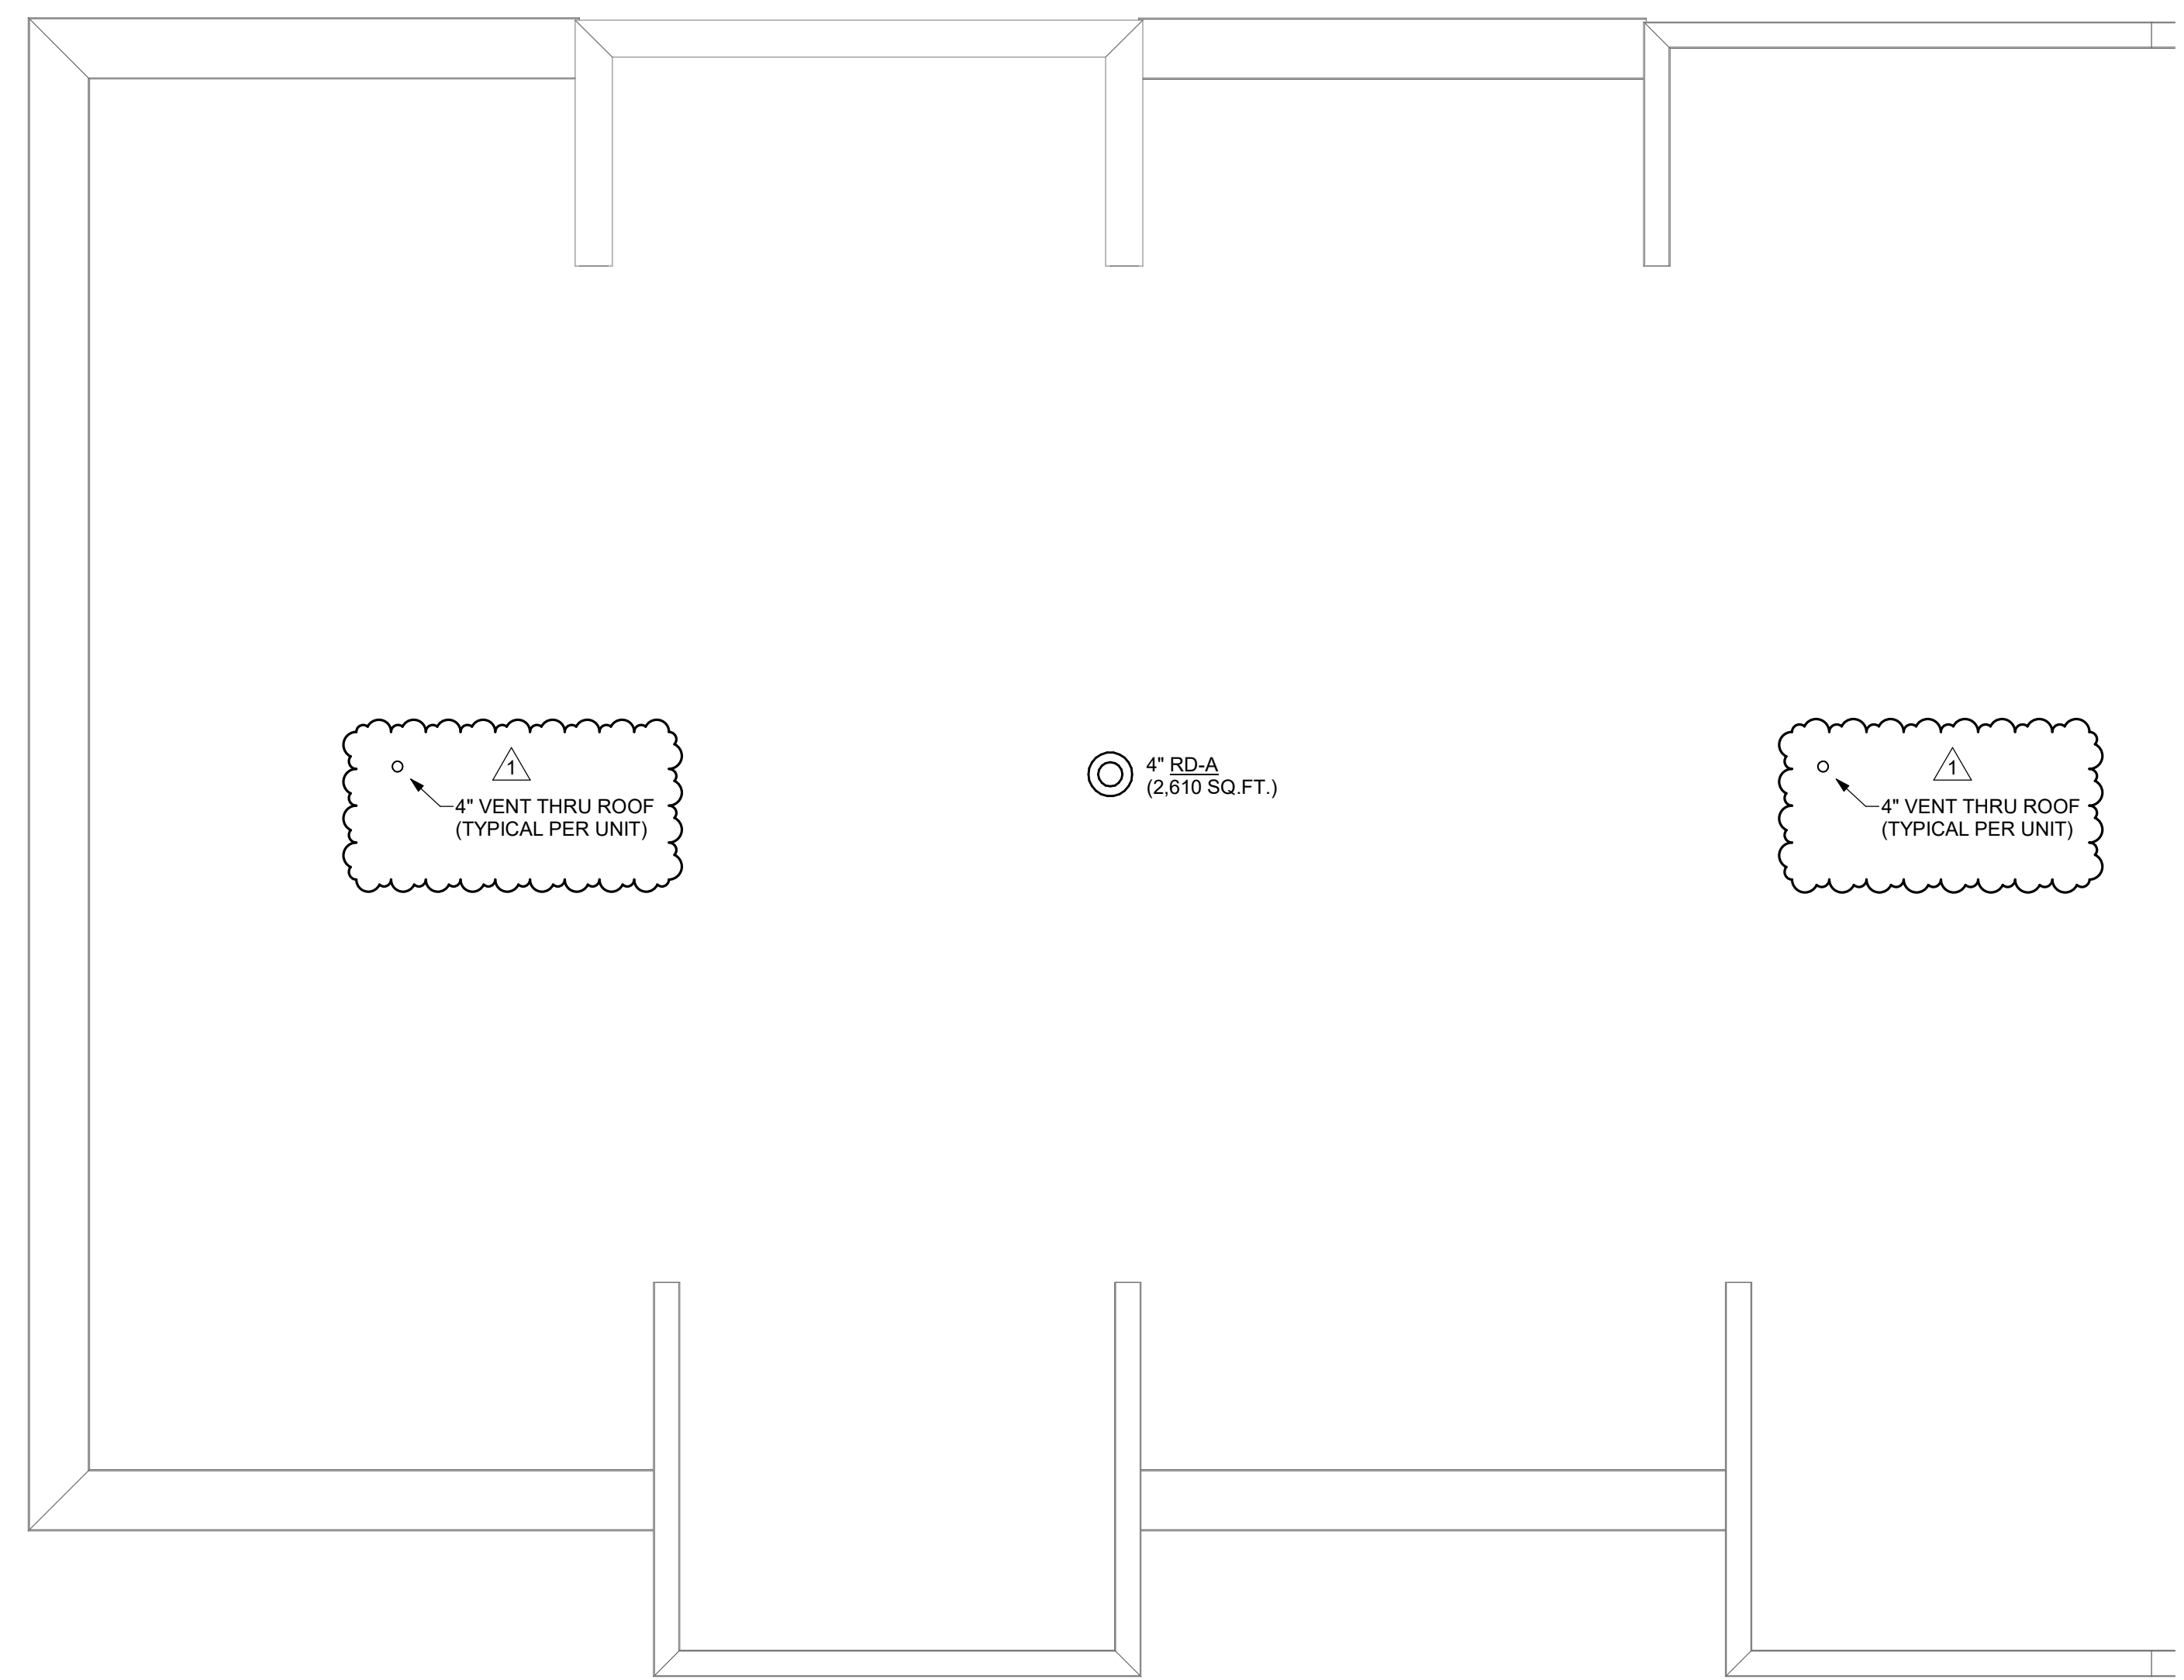

1 4 UNIT - ROOF PLAN - PLUMBING
P-103 1/4" = 1'-0"

SOME UNITS ARE OPPOSITE HAND

PROFESSIONAL SEAL

REVISIONS:	No.	Description	Date
	1	Addendum 1	02/08/19

PROJECT NAME:
New Construction:
The West End
240-260 Lakefront Blvd
Buffalo Ny, 14202

Issued for Permit: 01.23.2019
Drawn By: DMS2
Checked By: RKS

DRAWING NAME:
Roof Plan - Plumbing

DRAWING NO.:
P-103

Project No: 18.122