

PANELBOARD OM														
RATINGS: 120/208V, 3PH, 4W + G MOUNTING: SURFACE										BUS RATING: 400A MAIN RATING: MCB 400A MIN. SHORT CIRCUIT RATING: TBD AMPS				
LOAD (AMPS)			LOAD DESCRIPTION	BKR		CKT NO.		CKT NO.	BKR		LOAD DESCRIPTION	LOAD (AMPS)		
A	B	C		P	AMP				AMP	P		A	B	C
0				1	-	1	A	2	-	1		0		
	0			3	-	3	B	4	-	1			0	
		0		5	-	5	C	6	-	1				0
0				1	-	7	A	8	-	1		0		
	0			1	-	9	B	10	-	1			0	
		0		1	-	11	C	12	-	1				0
0				1	-	13	A	14	-	1		0		
	0			1	-	15	B	16	-	1			0	
		0		1	-	17	C	18	-	1				0
0				1	-	19	A	20	-	1		0		
	0			1	-	21	B	22	-	1			0	
		0		1	-	23	C	24	-	1				0
0				1	-	25	A	26	-	1		0		
	0			1	-	27	B	28	-	1			0	
		0		1	-	29	C	30	-	1				0
0				1	-	31	A	32	-	1		0		
	0			1	-	33	B	34	-	1			0	
		0		1	-	35	C	36	-	1				0
0				1	-	37	A	38	-	1		0		
	0			1	-	39	B	40	-	1			0	
		0		1	-	41	C	42	-	1				0
0				1	-	43	A	44	-	1				0
	0			1	-	45	B	46	-	1			0	
		0		1	-	47	C	48	-	1				0
0				1	-	49	A	50	-	1		0		
	0			1	-	51	B	52	-	1			0	
		0		1	-	53	C	54	-	1				0
0				1	-	55	A	56	-	1		0		
	0			1	-	57	B	58	-	1			0	
		0		1	-	59	C	60	-	1				0
0				1	-	61	A	62	-	1		0		
	0			1	-	63	B	64	-	1			0	
		0	1	-	65	C	66	-	1				0	
0			1	-	67	A	68	-	1		0			
	0		1	-	69	B	70	-	1			0		
		0	1	-	71	C	72	-	1				0	
0			1	-	73	A	74	-	1		0			
	0		1	-	75	B	76	-	1			0		
		0	1	-	77	C	78	-	1				0	
0			1	-	79	A	80	-	1		0			
	0		1	-	81	B	82	-	1			0		
		0	1	-	83	C	84	-	1				0	
COMMENTS:														
0.0	0.0	0.0	TOTAL AMPS - PHASE A, B, C											
0 KVA			0 AMPS		TOTAL CONNECTED LOAD									
0 KVA			0 AMPS		TOTAL DEMAND LOAD - NO SPARE									

PANELBOARD OS															
RATINGS: 120/208V, 3PH, 4W + G MOUNTING: SURFACE										BUS RATING: 60A MAIN RATING: MCB 60A MIN. SHORT CIRCUIT RATING: 10,000 AMPS					
LOAD (AMPS)			LOAD DESCRIPTION	BKR		CKT NO.	A	B	C	BKR		LOAD DESCRIPTION	LOAD (AMPS)		
A	B	C		P	AMP					AMP	P		A	B	C
0				1	-	1	A	2		-	1		0		
	0			1	-	3	B	4		-	1			0	
		0		1	-	5	C	6		-	1				0
0				1	-	7	A	8		-	1		0		
	0			1	-	9	B	10		-	1			0	
		0		1	-	11	C	12		-	1				0
0				1	-	13	A	14		-	1		0		
	0			1	-	15	B	16		-	1			0	
		0		1	-	17	C	18		-	1				0
0				1	-	19	A	20		-	1		0		
	0			1	-	21	B	22		-	1			0	
		0		1	-	23	C	24		-	1				0
0				1	-	25	A	26		-	1		0		
	0			1	-	27	B	28		-	1			0	
		0		1	-	29	C	30		-	1				0
COMMENTS:															
0.0	0.0	0.0	TOTAL AMPS - PHASE A, B, C												
0 KVA			0 AMPS		TOTAL CONNECTED LOAD										
0 KVA			0 AMPS		TOTAL DEMAND LOAD - NO SPARE										

OFFICE:
JOB NO. 0459-26-001

THE WESSON GROUP

PRATTSBURGH, NY

DRAWN BY: BDM

DATE: 01/23/2026

CHECKED BY: -

DATE: -

REVISED DATE:

REVISED DATE:

REVISED DATE:

REVISED DATE:


SHEET NAME: PANELS & SPECIFICATIONS

 
SHEET NO: E0.2

OF: E3.1

Paragon Engineering Services Inc. shall retain all common law, statutory and other reserved rights, including copyright to all drawings, specifications, electronic data, and any other instruments of service furnished to the Owner for use with respect to this project. These documents may not be used by any other party, for this project or for any other project without written consent from Paragon Engineering Services Inc.

Feb 02, 2026, 3:31 PM - BDM
P:\0459-26-001 - Prattsburgh Wind Farm\constructs\Electrical\0459-26-001-E1.1.dwg

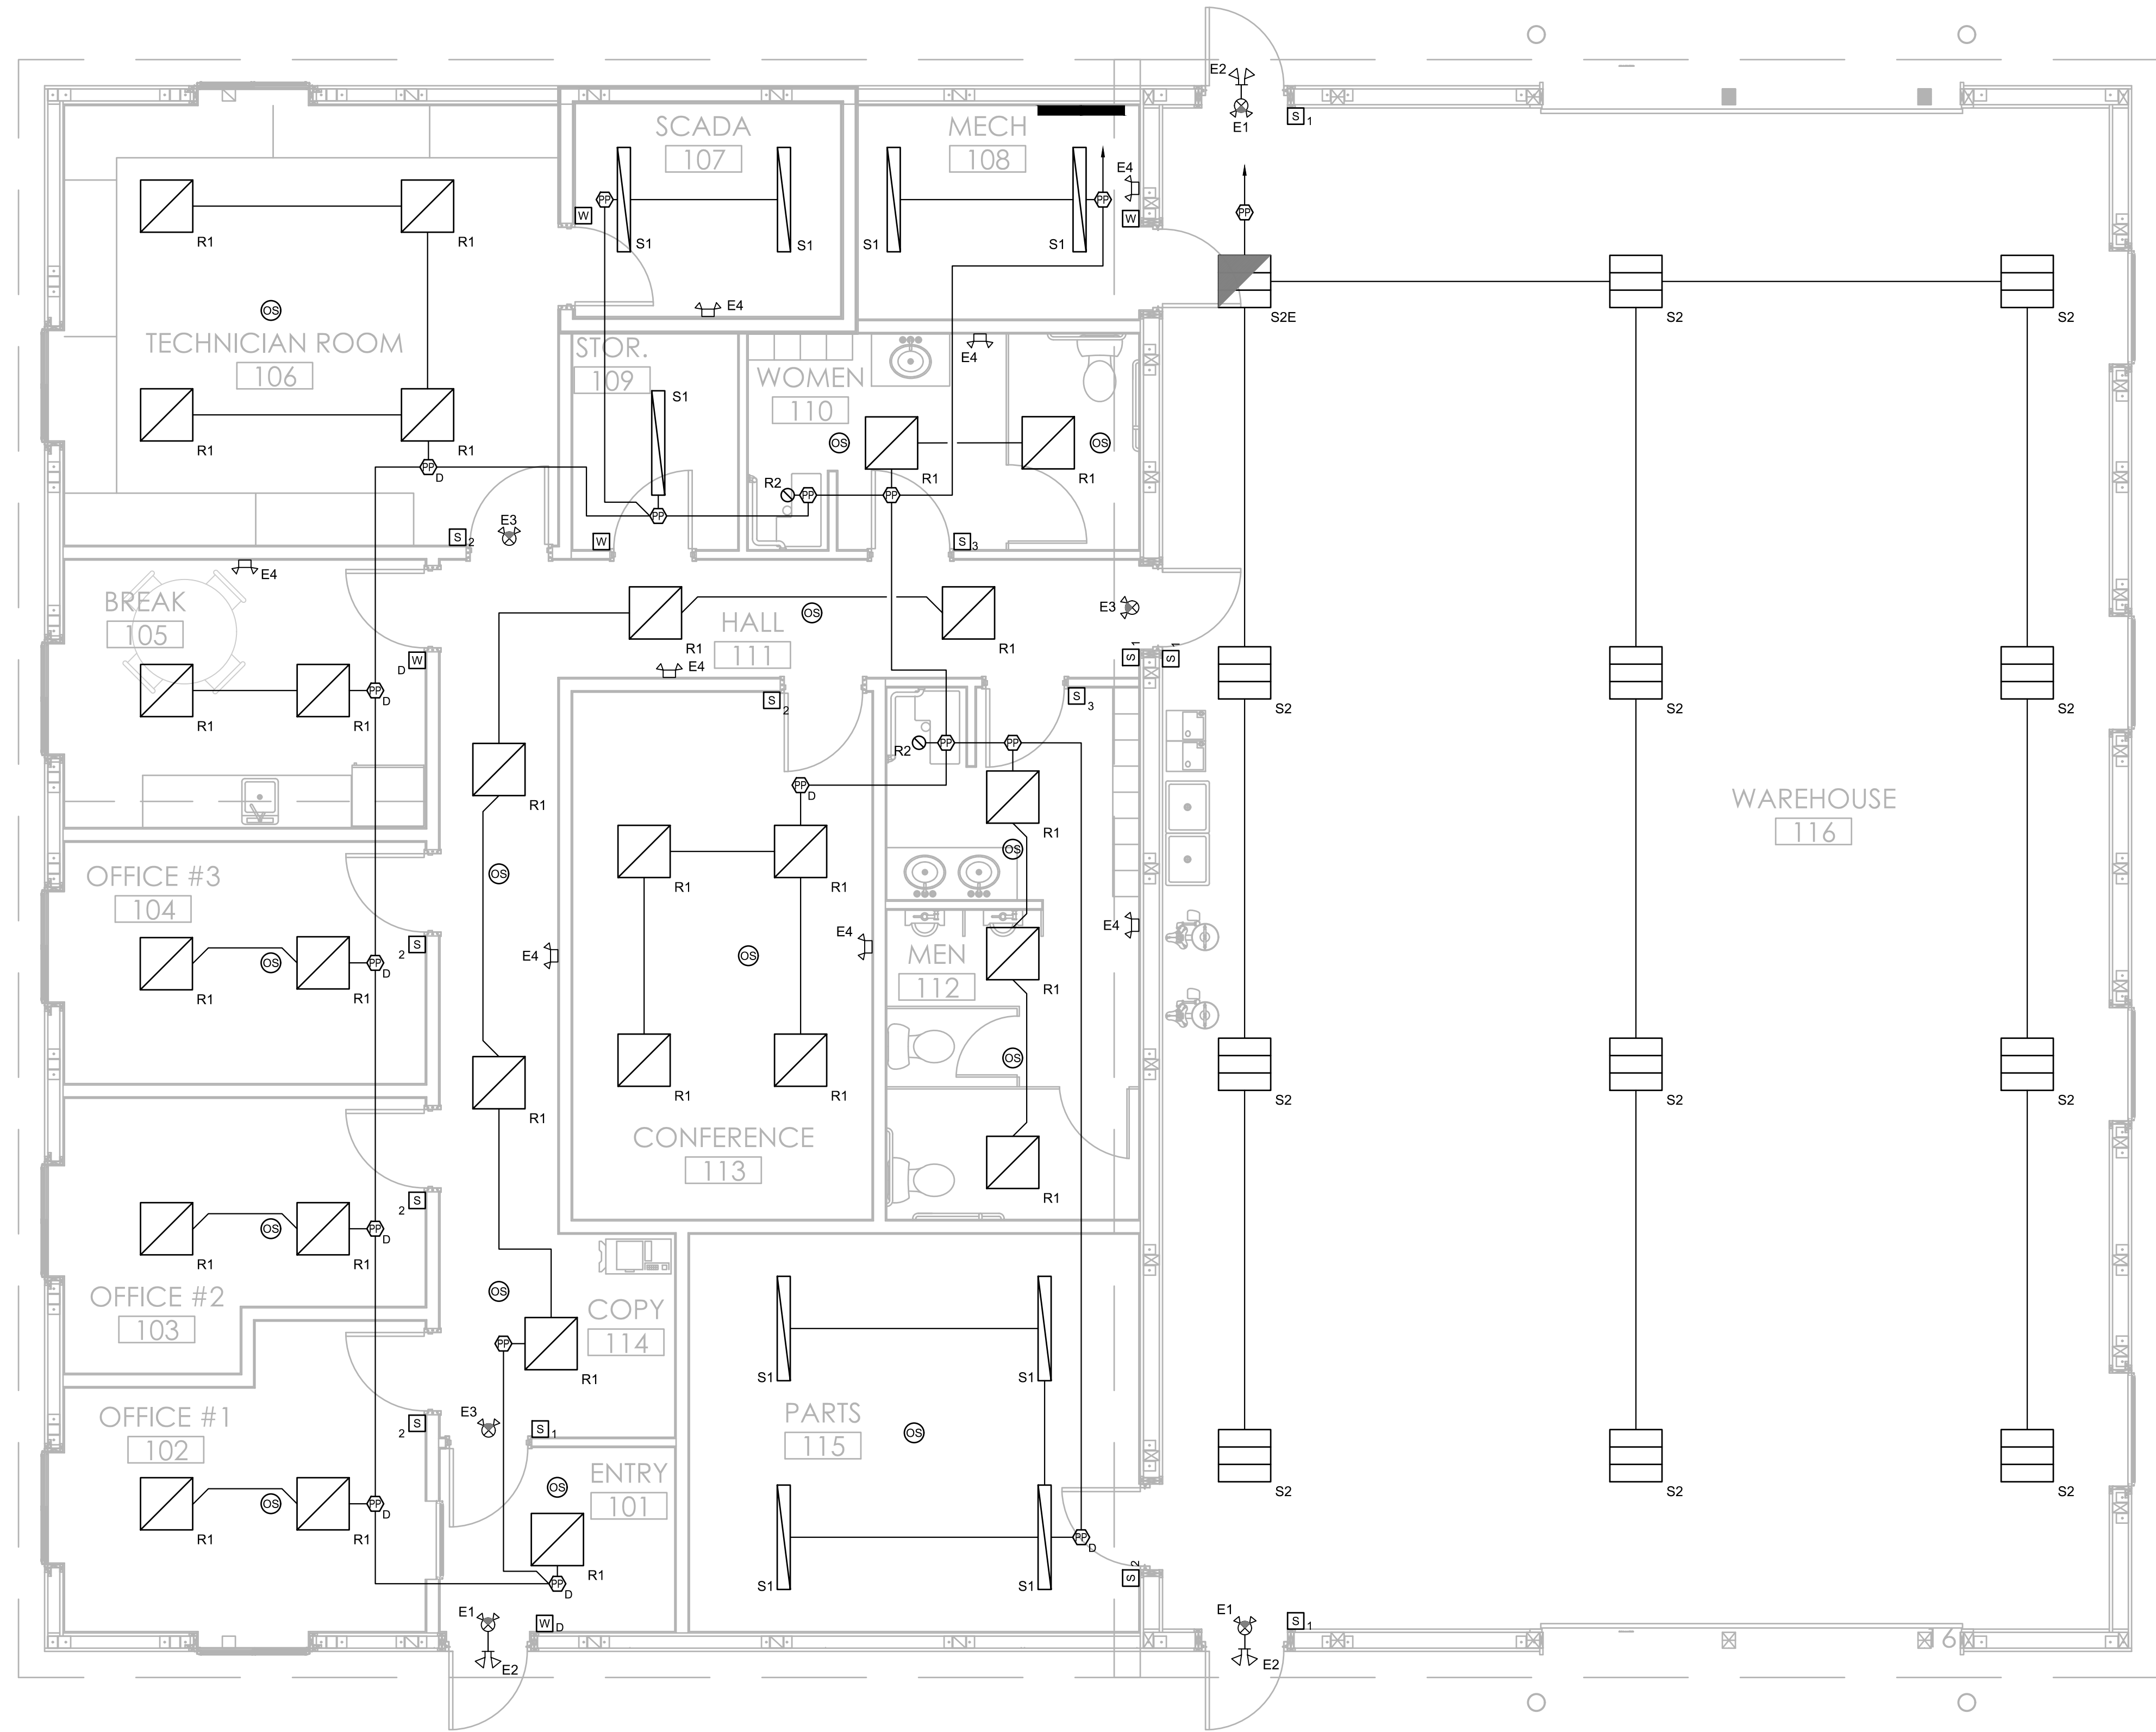

  **FLOOR PLAN - LIGHTING**
1/4" = 1'-0"

ELECTRICAL NOTES: # (THIS SHEET ONLY)

1. ...



50% PROGRESS SUBMISSION

DRAWN BY:	BDM
DATE:	01/23/2026
CHECKED BY:	-
DATE:	-
REVISED DATE:	
REVISED DATE:	
REVISED DATE:	


SHEET NAME:	FLOOR PLAN - LIGHTING
SHEET NO.:	E1.1
OF:	E3.1


OFFICE:
JOB NO.
0459-26-001

THE WESSON GROUP

PRATTSBURGH, NY

 Paragon Engineering Services Inc. shall retain all common law, statutory and other reserved rights, including copyright to all drawings, specifications, electronic data, and any other instruments of service furnished to the Owner for use with respect to this project. These documents may not be used by any other party, for this project or for any other project without written consent from Paragon Engineering Services Inc.

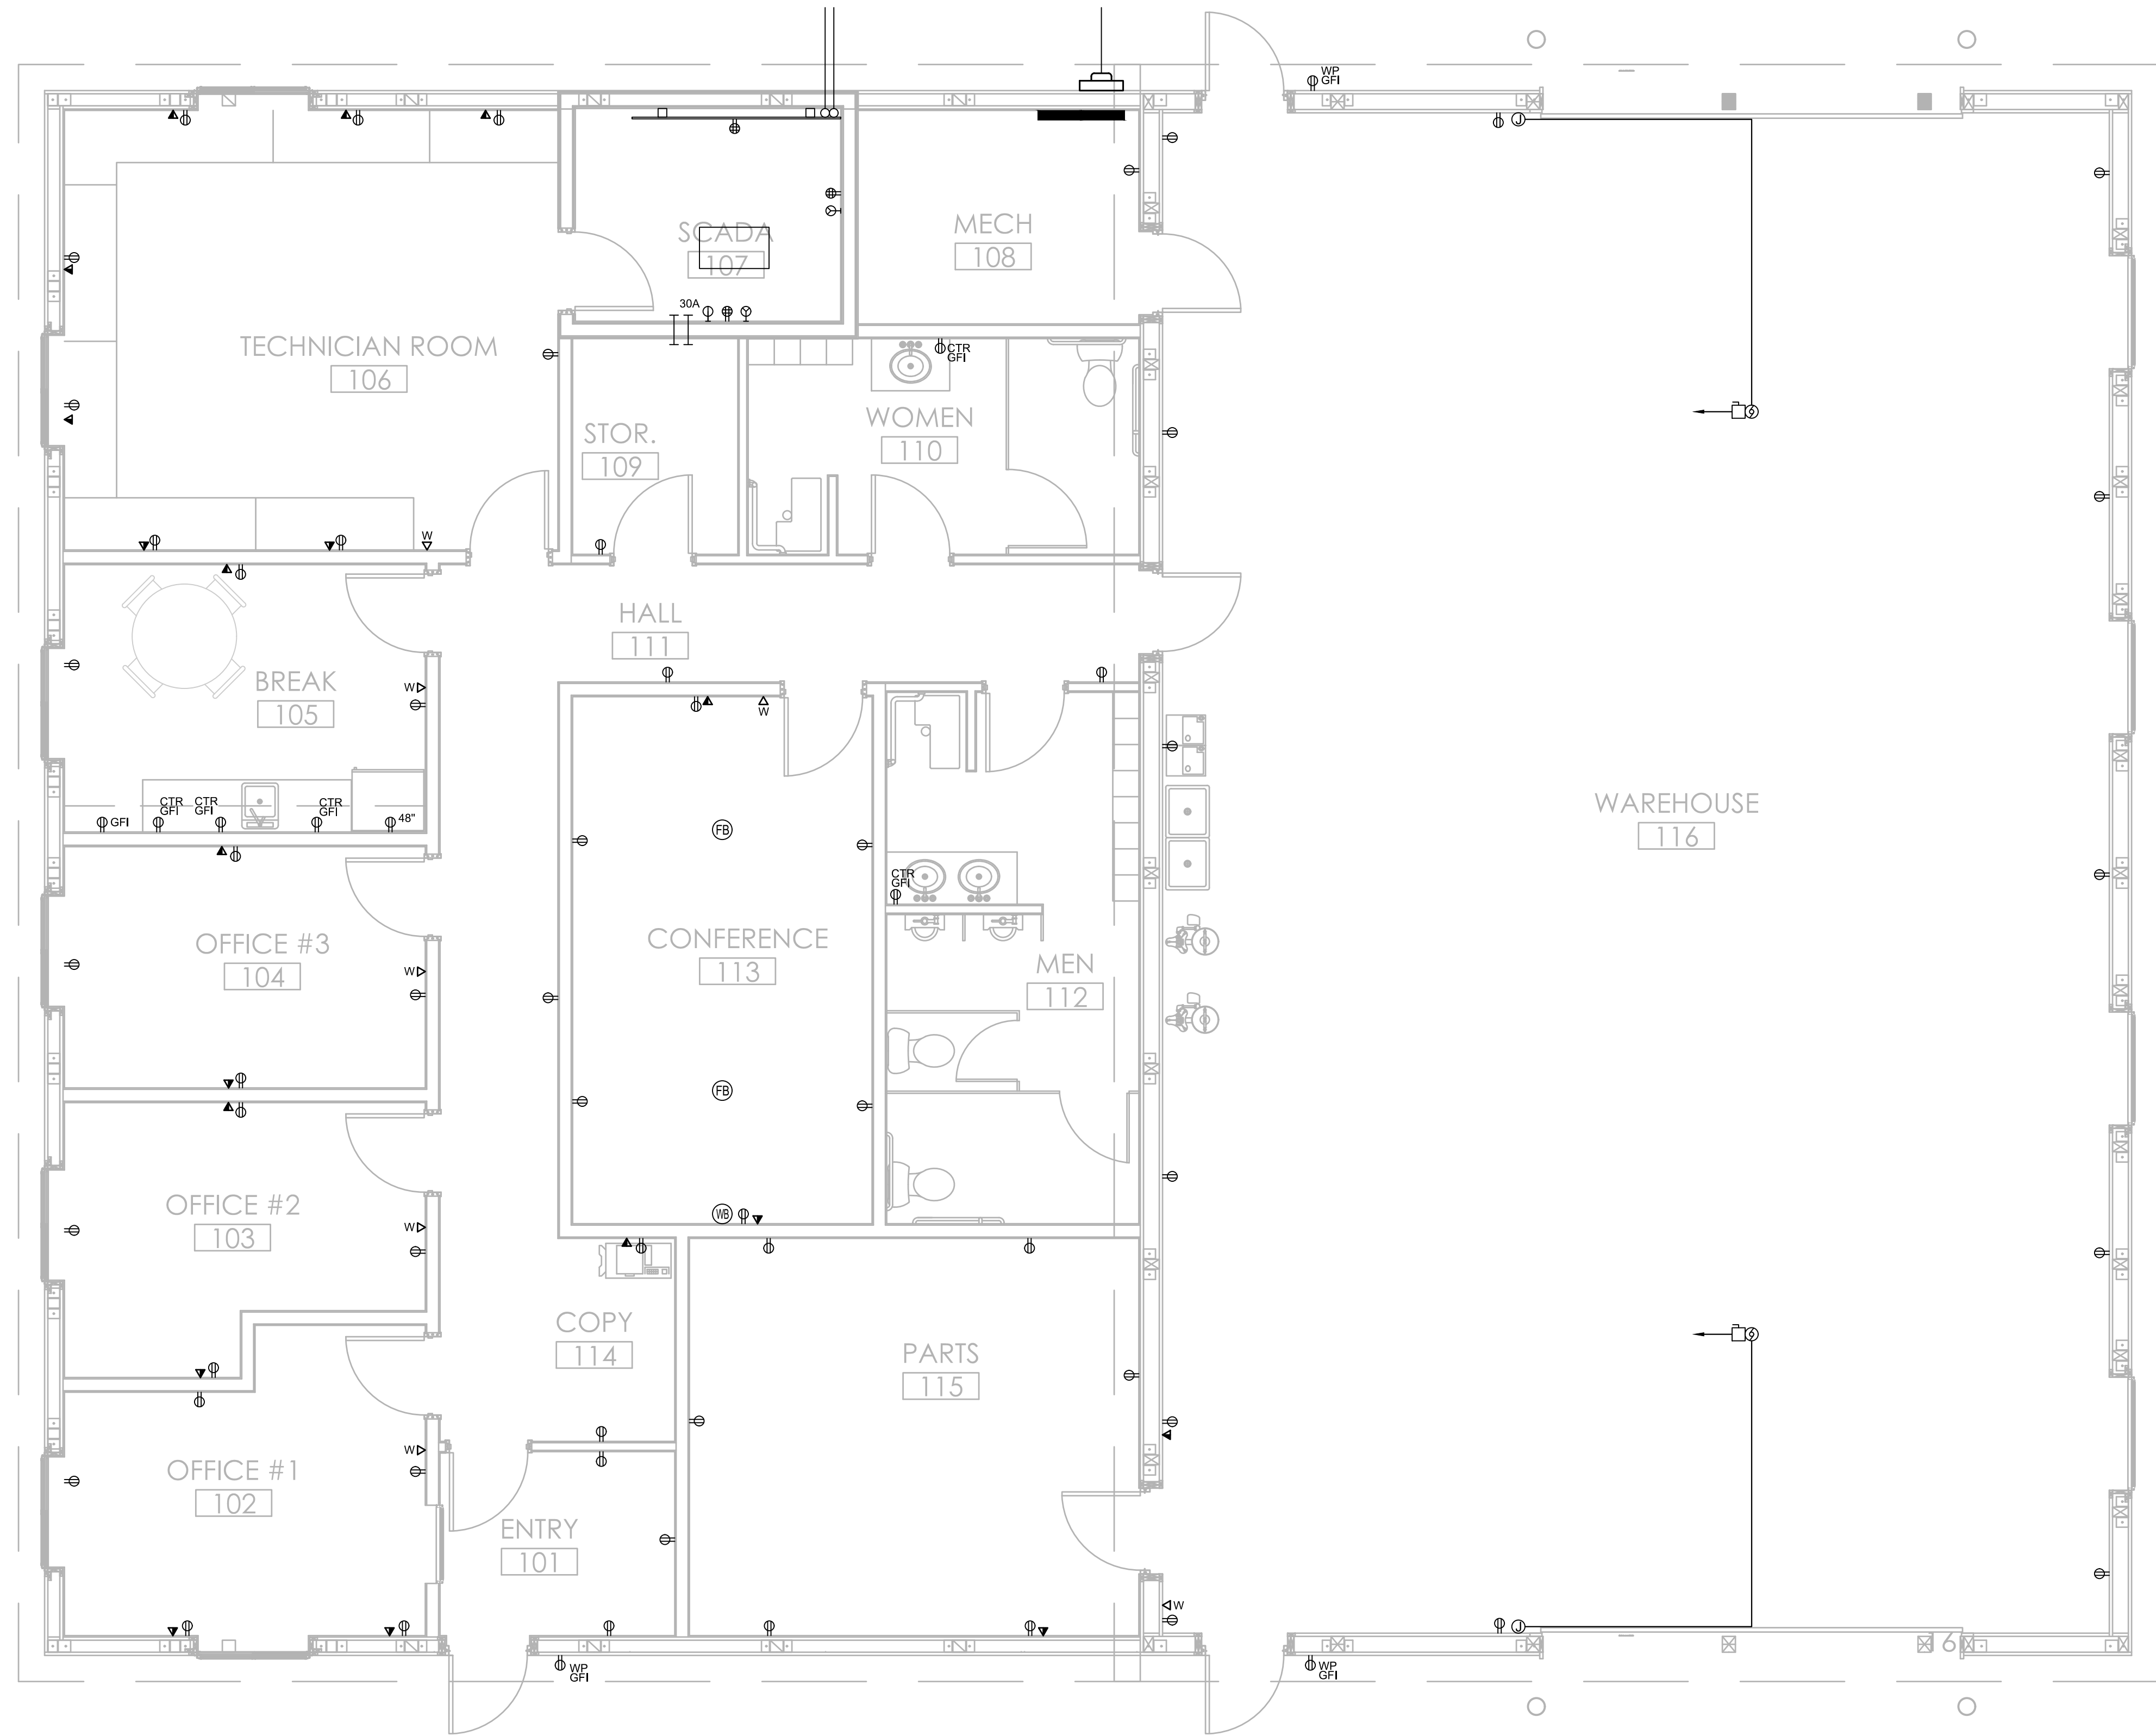

 **FLOOR PLAN - POWER**
1
E2.1
1/4" = 1'-0"

ELECTRICAL NOTES: Ⓢ (THIS SHEET ONLY)


1. ...

50% PROGRESS SUBMISSION

OFFICE: JOB NO. 0459-26-001	
THE WESSON GROUP PRATTSBURGH, NY	
DRAWN BY: BDM DATE: 01/23/2026 CHECKED BY: - DATE: - REVISED DATE: REVISED DATE: REVISED DATE:	
SHEET NAME: FLOOR PLAN - POWER SHEET NO.: E2.1 OP: E3.1	


Paragon Engineering Services Inc. shall retain all common law, statutory and other reserved rights, including copyright to all drawings, specifications, electronic data, and any other instruments of service furnished to the Owner for use with respect to this project. These documents may not be used by any other party, for this project or for any other project without written consent from Paragon Engineering Services Inc.

Feb 02, 2026, 3:31 PM - BDM
P:\0459-26-001 - Prattsburgh Wind Farm\constructs\Electrical\0459-26-001-E2.2.dwg

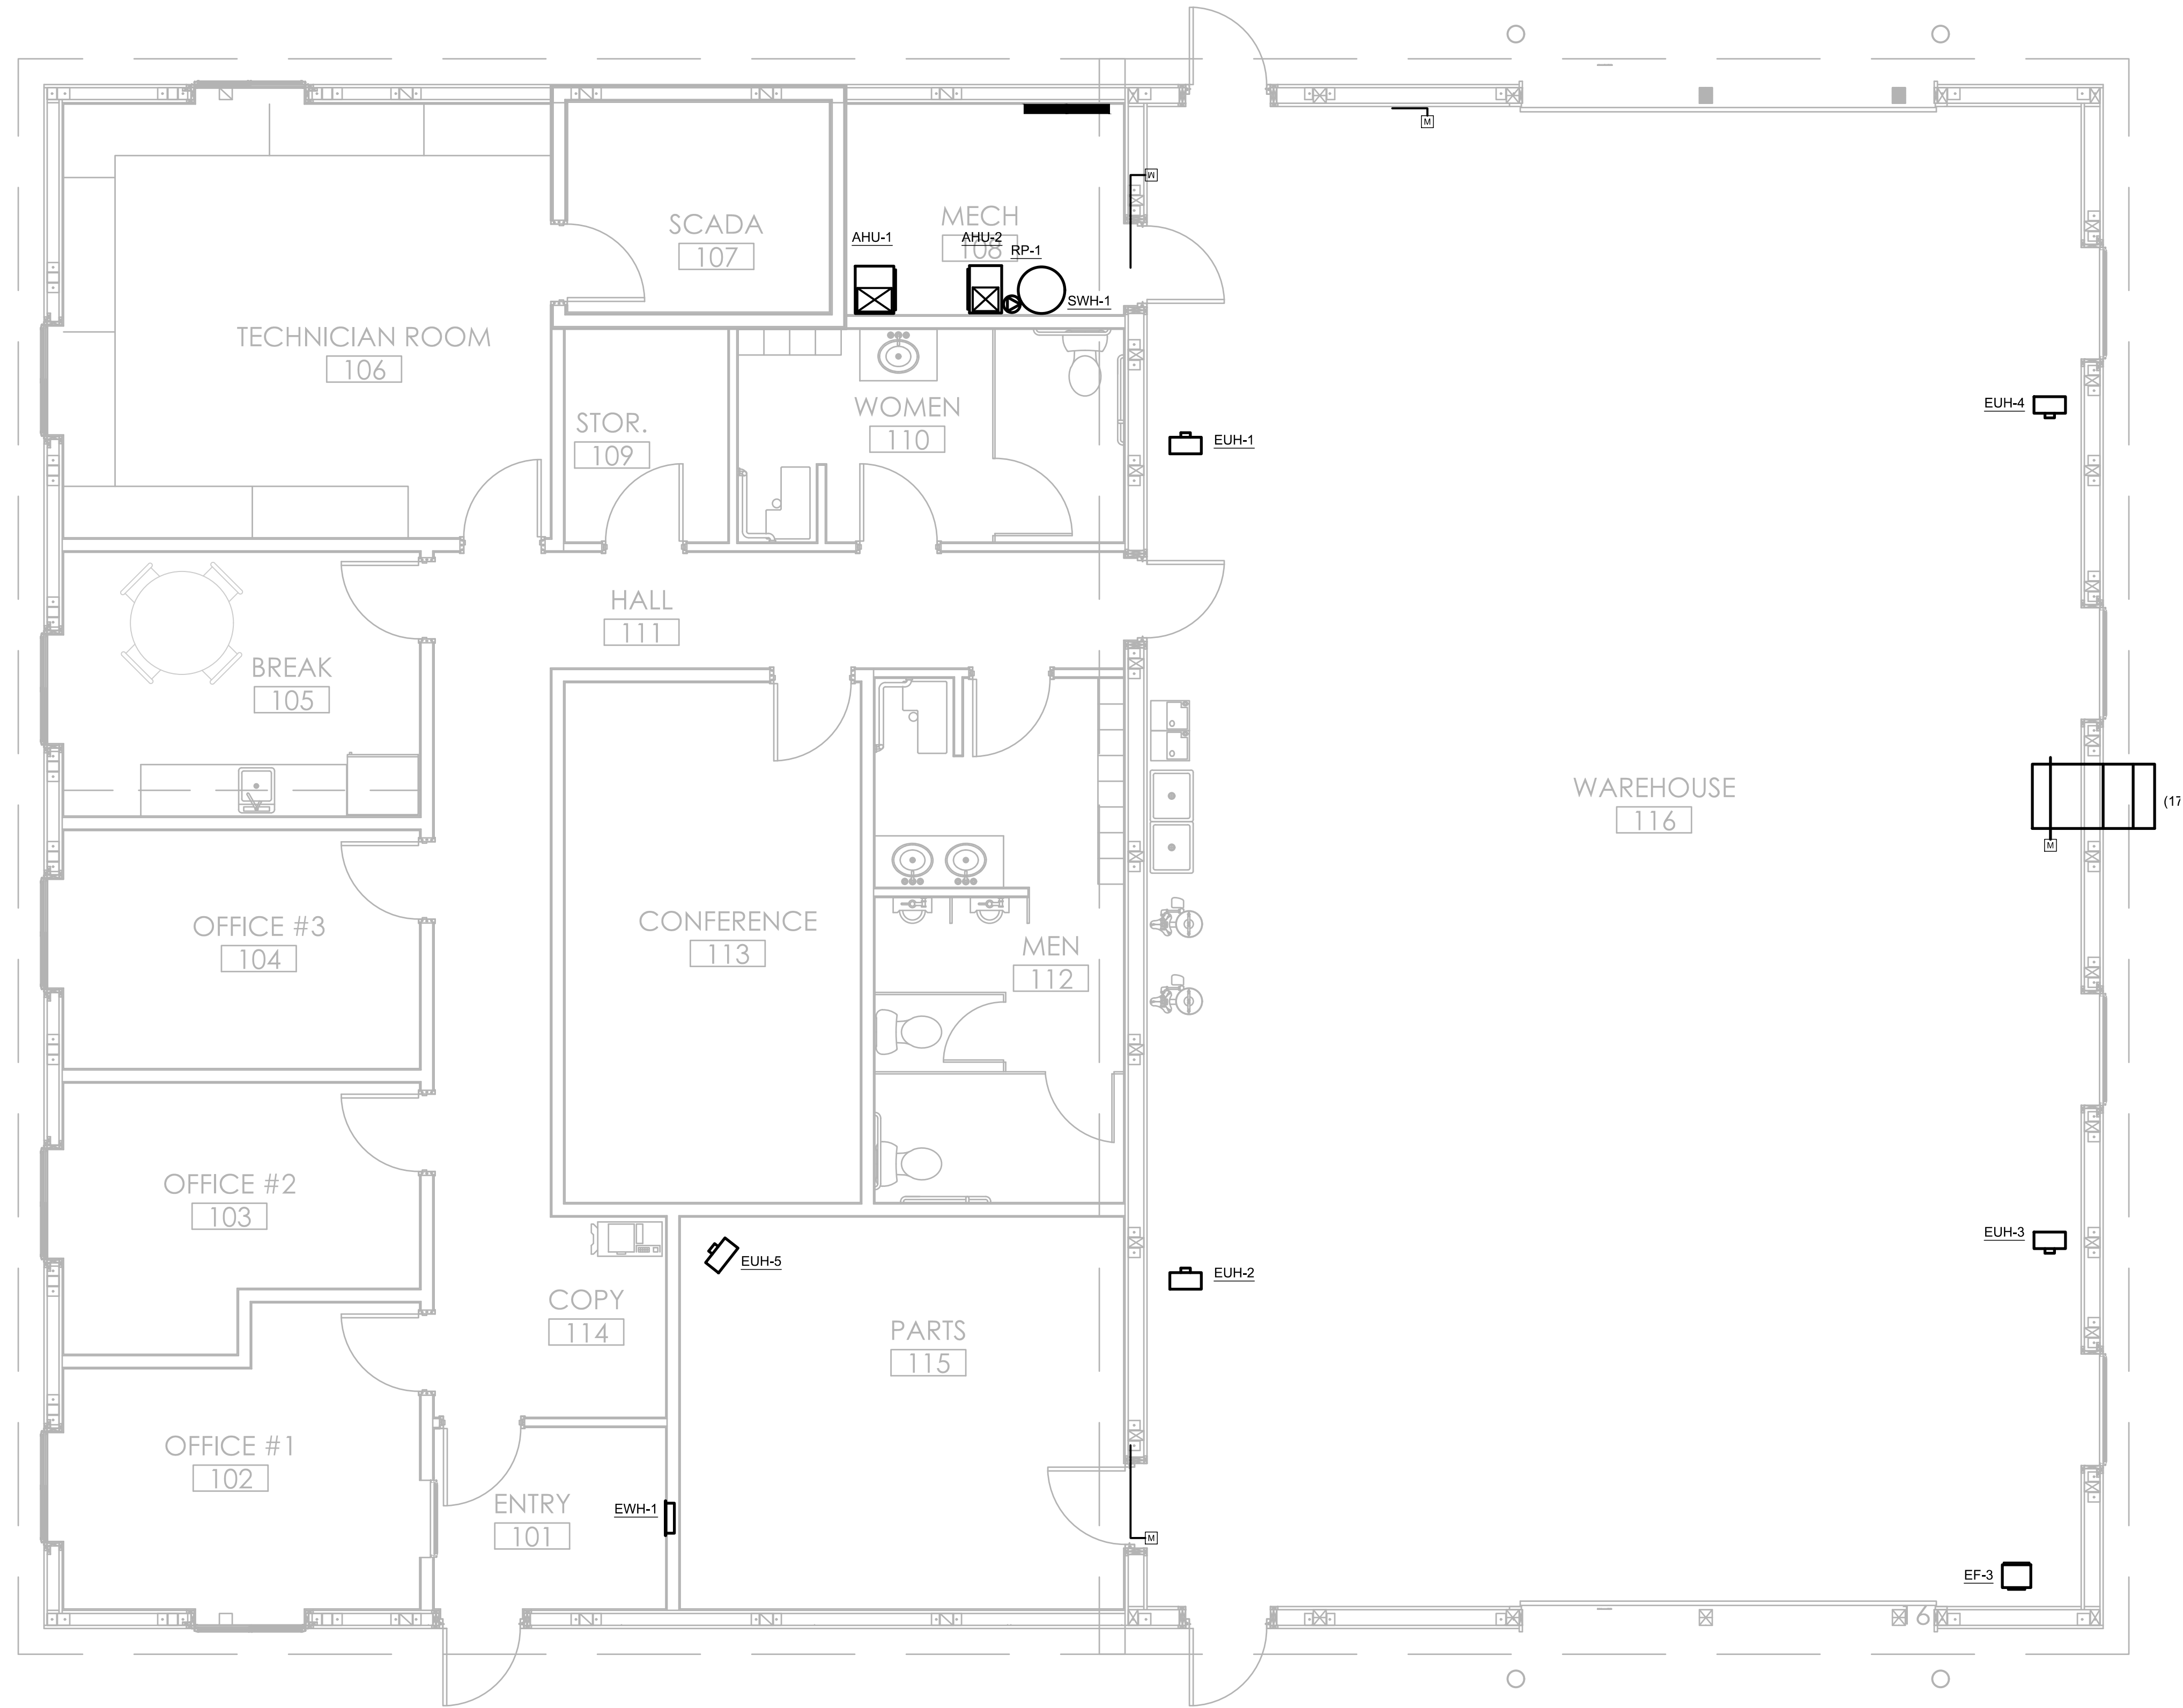

ELECTRICAL NOTES: Ⓢ (THIS SHEET ONLY)

 1. ...



1
E2.1

FLOOR PLAN - MECH POWER

1/4" = 1'-0"




50% PROGRESS SUBMISSION

OFFICE:
JOB NO. 0459-26-001

THE WESSON GROUP
PRATTSBURGH, NY

DRAWN BY:	BDM
DATE:	01/23/2026
CHECKED BY:	-
DATE:	-
REVISED DATE:	
REVISED DATE:	
REVISED DATE:	

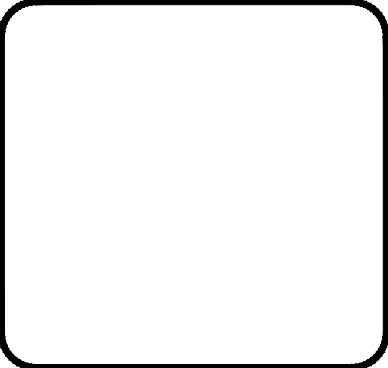

SHEET NAME: FLOOR PLAN - MECH POWER	OF:
SHEET NO: E2.2	E3.1

Paragon Engineering Services Inc. shall retain all common law, statutory and other reserved rights, including copyright to all drawings, specifications, electronic data, and any other instruments of service furnished to the Owner for use with respect to this project. These documents may not be used by any other party, for this project or for any other project without written consent from Paragon Engineering Services Inc.